


BUILDING AND STRUCTURE INDEX
NO. NAME

- 201 GENERAL SITE
- 202 SIPHONS AND SIPHON SHAFT
- 203 PRELIMINARY TREATMENT FACILITY (J32021)
- 204 INFLUENT FLOW METER VAULT & HIGH LEVEL/INLINE JUNCTION BOX
- 205 PRIMARY INFLUENT CONDUITS OR CHANNELS
- 206 PRIMARY CLARIFIERS (J33031)
- 207 (NOT USED)
- 208 PRIMARY EFFLUENT CONDUITS OR CHANNELS
- 209 FLOW CONTROL STRUCTURE
- 210 MIX CHANNEL
- 211 MIXED LIQUOR STRUCTURE
- 212 (NOT USED)
- 213 WEST PLANT MIXED LIQUOR CHANNELS
- 214 EAST PLANT MIXED LIQUOR CHANNELS
- 215 (NOT USED)
- 216 INLINE FLOW SYSTEM
- 217 (NOT USED)
- 218 WEST PLANT AERATION BASINS
- 219 EAST PLANT AERATION BASINS
- 220 AERATED EFFLUENT CONDUITS OR CHANNELS
- 221 WEST PLANT SECONDARY CLARIFIERS
- 222 EAST PLANT SECONDARY CLARIFIERS
- 223 NEW EAST PLANT SECONDARY CLARIFIERS
- 224 SECONDARY EFFLUENT CONDUITS OR CHANNELS
- 225 PROCESS AIR COMPRESSOR BUILDING
- 226 (NOT USED)
- 227 (NOT USED)
- 228 SALT & GRAVEL STORAGE BIN (J0090X010)(04M2650-1)
- 229 MILORGANITE CHAFF DUMPING STATION (J0090X010)
- 230 (NOT USED)
- 231 (NOT USED)
- 232 (NOT USED)
- 233 RAS PIPES, CONDUITS OR CHANNELS
- 234 RAS PUMP STATION
- 235 WAS PUMP STATION
- 236 (NOT USED)
- 237 PICKLE LIQUOR FACILITY
- 238 (NOT USED)
- 239 (NOT USED)
- 240 (NOT USED)
- 241 (NOT USED)
- 242 CHLORINE CONTACT BASIN
- 243 CHEMICAL UNLOADING FACILITY (J61611)
- 244 (NOT USED)
- 245 DISINFECTION BUILDING
- 246 (NOT USED)
- 247 EFFLUENT PUMP STATION
- 248 PLANT EFFLUENT CHANNELS
- 249 PLANT EFFLUENT OUTFALL
- 250 INTERIM OUTFALL
- 251 (NOT USED)
- 252 (NOT USED)
- 253 (NOT USED)
- 254 (NOT USED)
- 255 (NOT USED)
- 256 THICKENING BUILDING (J51621)
- 257 EQUALIZATION AND BLEND FACILITY
- 258 DEWATERING AND DRYING FACILITY (J51631)
- 259 STORM WATER PUMP STATION (J26-MS-100)
- 260 MILORGANITE STORAGE FACILITY (J51871)
- 261 MILORGANITE PACKAGING FACILITY (NOT BUILT)
- 262 INLINE SOLIDS HANDLING FACILITY (I37621 // 87-499 TO 541)
- 263 INTRIM TRUCK LOADING FACILITY (DEMO, J0076X020)
- 263 (NOT USED)
- 263A TUNNEL VENTILATION FAH BUILDING
- 263B SOLIDS HANDLING AREA
- 263C INLINE PUMP STATION SURFACE STRUCTURE
- 263D EQUIPMENT SHAFT
- 263E INLINE PUMP-OUT
- 264 (NOT USED)
- 265 (NOT USED)
- 266 GALLERY ACCESS ('BUS STOP')
- 267 PRIMARY TREATMENT GALLERIES
- 268 EAST PLANT GALLERIES
- 269 WEST PLANT GALLERIES
- 270 NEW EAST PLANT CLARIFIER GALLERIES
- 271 WAS GALLERY
- 272 DISINFECTION GALLERY
- 273 SOLIDS GALLERY
- 274 NONPROCESS GALLERIES
- 275 CHEMICAL FEED PIPE TRENCH
- 276 MILORGANITE PIPE TRENCH
- 277 (NOT USED)
- 278 BUILDING & GROUNDS FACILITY (J73041)
- 279 OPERATIONS BUILDING (J72611)
- 279A FOAM BUILDING (J72611 // 279-AS-1)
- 280 MAINTENANCE FACILITY (J73021)
- 280A COMPRESSED GAS STORAGE (J0090X020)(construction2000)
- 281 NORTH UTILITY PUMP STATION (J63011)
- 282 FUEL OIL STORAGE TANKS (J0076X020 // 289-MA-93)
- 283 LP GAS FACILITY
- 284 VEHICLE FUEL STATION (J0090X020)(construction2000)
- 285 GARAGE
- 286 PRIMARY SWITCHING STATION
- 287 ELECTRICAL SUBSTATION
- 288 SECONDARY MOTOR CONTROL BUILDING
- 289 POWER HOUSE
- 289A POWER HOUSE -- BOILER ROOM ADDITION (J0076X020)
- 290 TRUCK WEIGH STATION
- 291 RAIL WEIGH STATION
- 292 GAS METER
- 293 GATE HOUSE (NOT BUILT)
- 294 (NOT USED)
- 295 LABORATORY
- 296 LAXEFILL
- 297 STACK
- 298 (NOT USED)
- 299 MAIN GATE - AUTOMATED (201CF1.dgn)

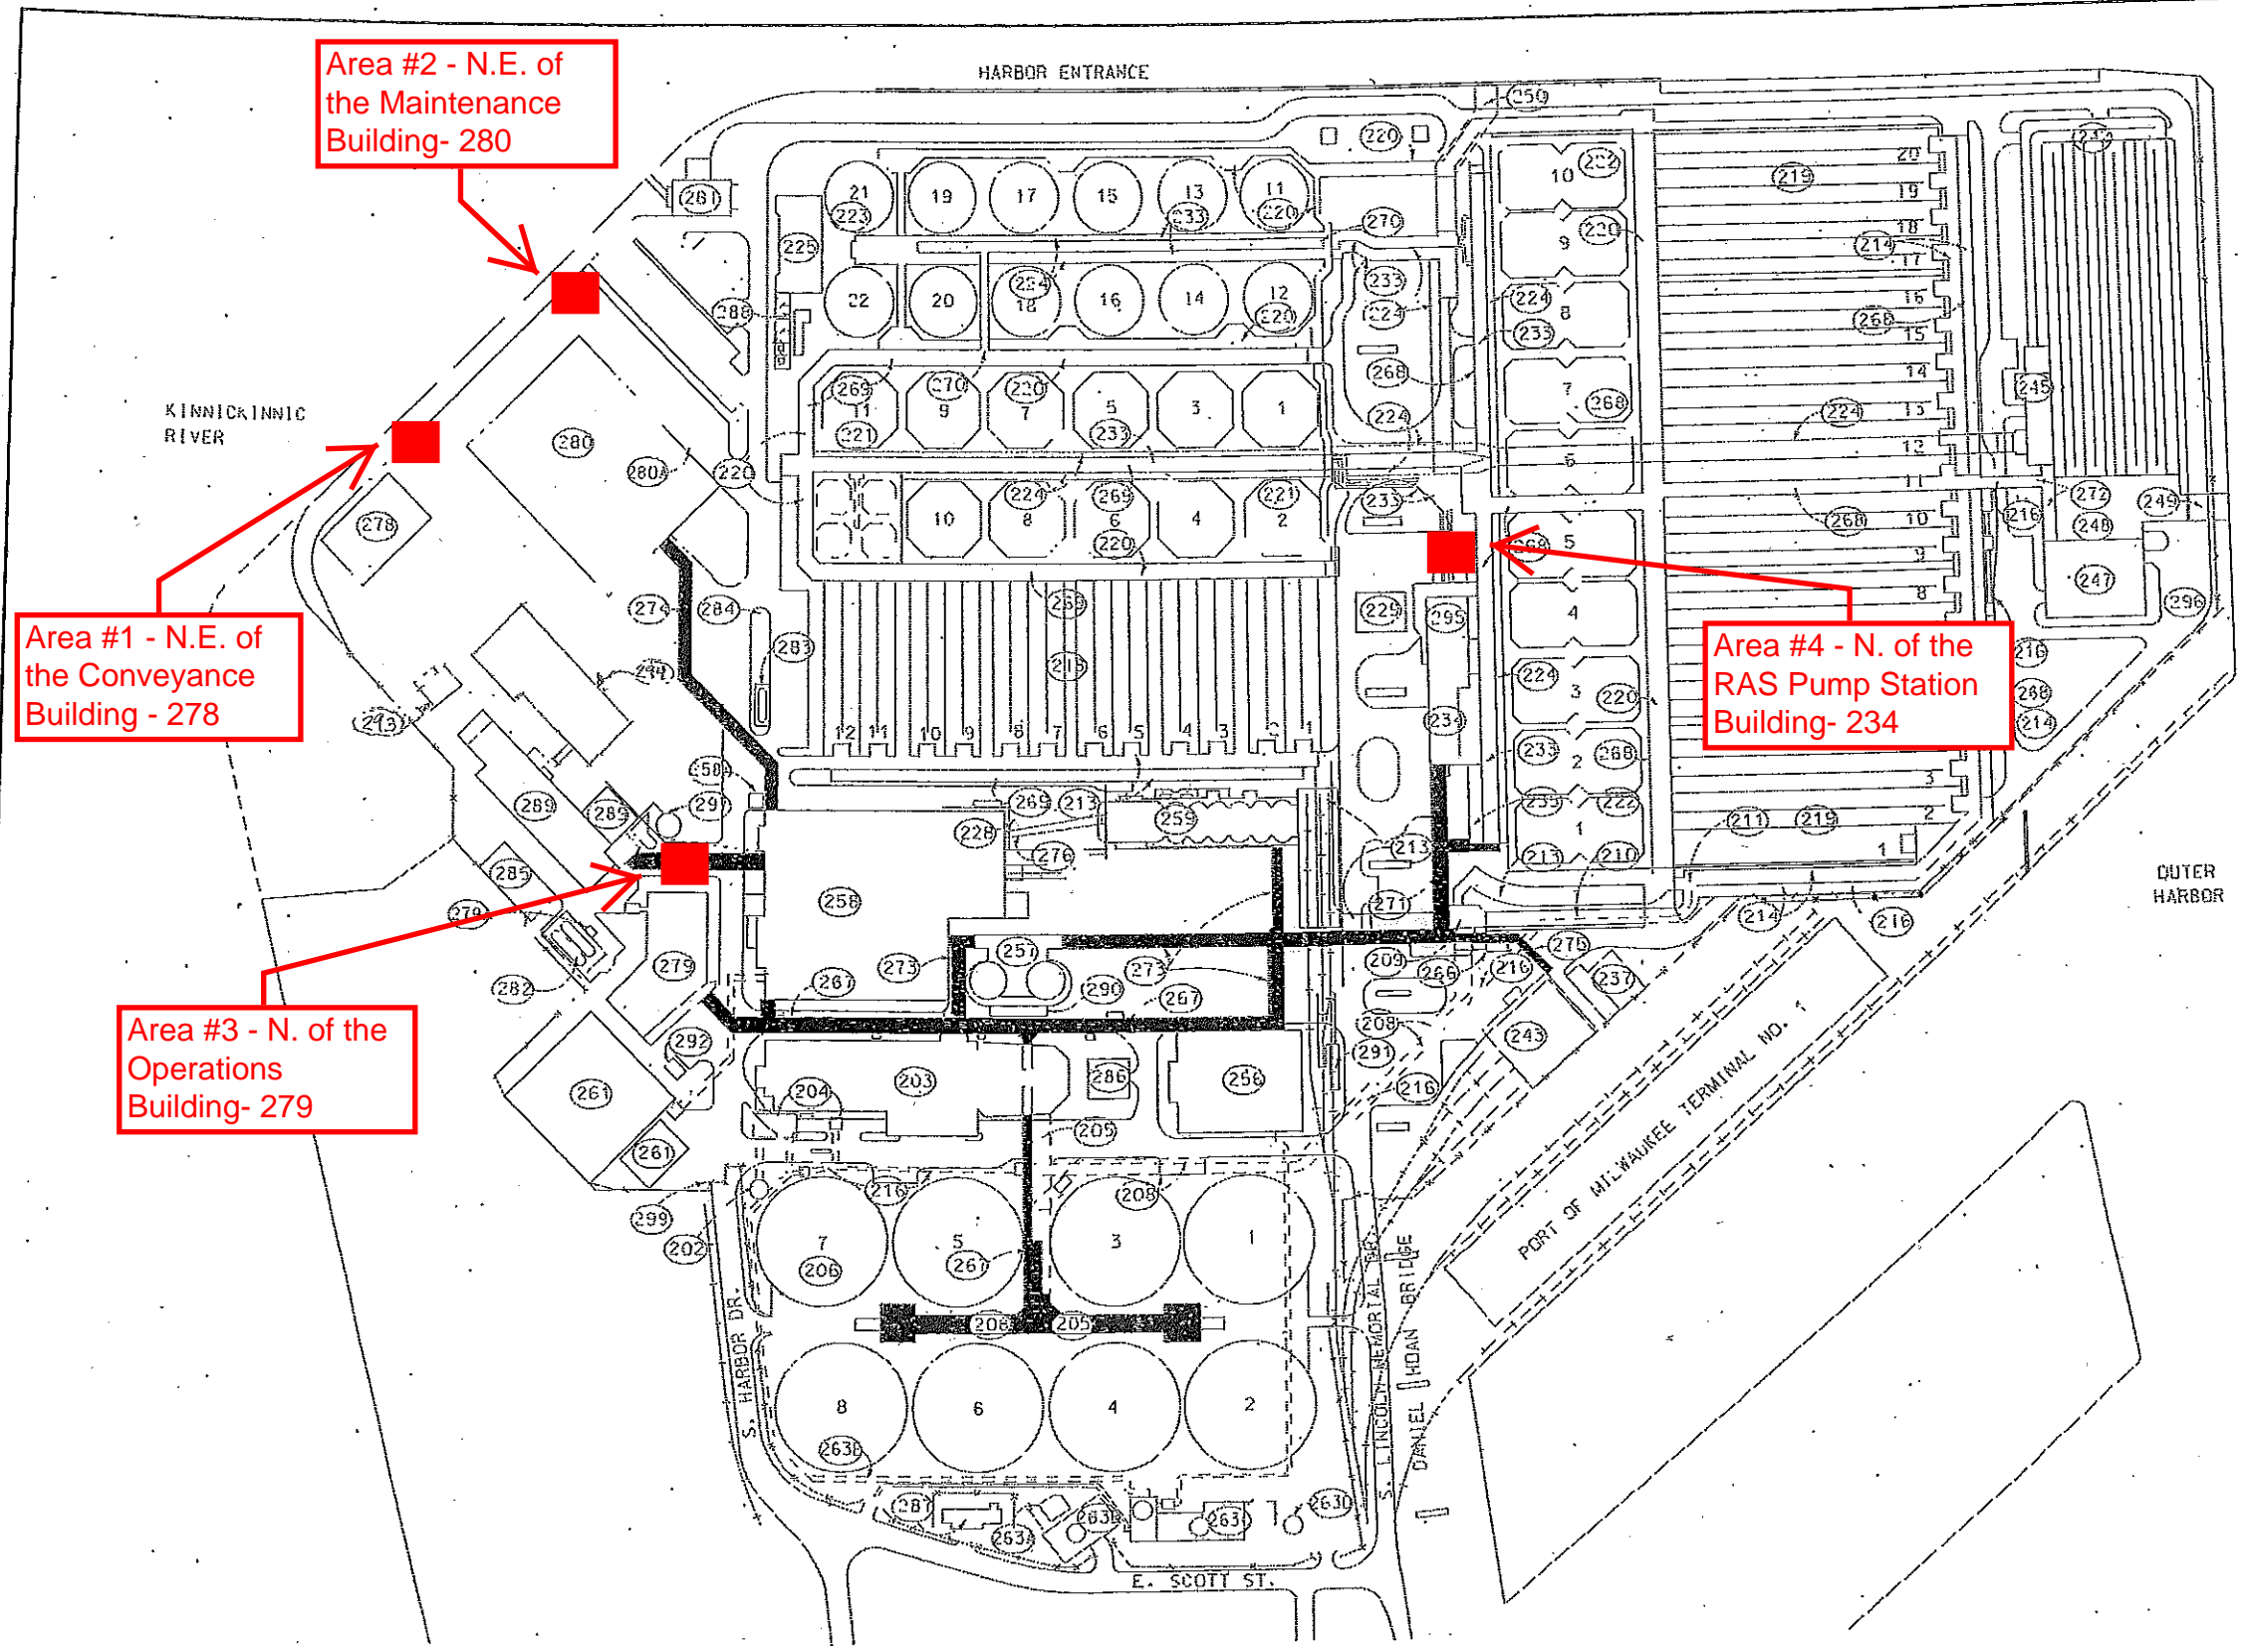

Designated Smoking Areas (#1 thru #4) - Effective 12/17/14

JONES ISLAND SITE PLAN
1"=120'


UNDERGROUND GALLERY

RECORD DRAWING

<p>REUSE OF DOCUMENTS THIS DOCUMENT AND THE IDEAS AND DESIGNS INCORPORATED HEREIN IS AN INSTRUMENT OF PROFESSIONAL SERVICE AND IS NOT TO BE USED, IN WHOLE OR IN PART, FOR ANY OTHER PROJECT WITHOUT THE WRITTEN AUTHORIZATION OF THE MILWAUKEE METROPOLITAN SEWERAGE DISTRICT.</p>		<p>VERIFY SCALES BAR IS ONE INCH ON ORIGINAL DRAWING IF NOT ONE INCH ON THIS SHEET, ADJUST SCALES ACCORDINGLY.</p>		<p>DSGN M. DUPONT DR J. FLEISCHFRESSER CHK M. DUPONT APVD T. ROWETT</p>		<p>This Design Prepared For MMSD By: RUST HARZA A JOINT VENTURE IN ASSOCIATION WITH KAPUR & ASSOCIATES, INC.</p>		<p>REV. NO. 01/2012 DATE RECORD DRAWING -- NO REDLINE CHANGES REVISION DESCRIPTION</p>		<p>TV ML BY APVD MMSD Preserving The Environment - Improving Water Quality</p>		<p>MILWAUKEE METROPOLITAN SEWERAGE DISTRICT METROPOLITAN INTERCEPTOR SEWER SYSTEM HARBOR SIPHONS JONES ISLAND GENERAL JONES ISLAND SITE PLAN</p>		<p>DRAWING NO.: 100-G-05 SHEET: 5 DATE: January 2006 CONTRACT: C07010C02 MMSD FILE: 15-005.dgn</p>	
--	--	---	--	---	--	--	--	---	--	---	--	--	--	---	--

FACILITY & STRUCTURE INDEX

NO.	NAME
301	GENERAL SITE
302	(NOT USED)
303	PRELIMINARY TREATMENT FACILITY
303	TEMPORARY ELECTRIC BUILDING
304	(NOT USED)
305	PRIMARY INFLUENT CONDUITS (303-14-S & 301-U-15)
306	PRIMARY CLARIFIERS (WEST)
307	PRIMARY CLARIFIERS (EAST)
308	PRIMARY EFFLUENT CHANNEL
309	SOLID HANDLING BUILDING
310	LOWER SITE SANITARY PUMP STATION
311	CENTRAL CONTROL BUILDING
312	(NOT USED)
313	(NOT USED)
314	(NOT USED)
315	SECONDARY DIVERSION CONDUIT
316	AERATION BUILDING (WEST)
317	AERATION BUILDING (EAST)
318	AERATION BASIN (WEST)
319	AERATION BASIN (EAST)
320	AERATION EFFLUENT CHANNEL
321	SECONDARY CLARIFIERS (WEST)
322	SECONDARY CLARIFIERS (EAST)
323	SECONDARY CLARIFIERS (NEW)
324	SECONDARY EFFLUENT CHANNELS
325	(NOT USED)
326	BLOWER & GENERATOR BUILDING
327	SECONDARY CONTROL BUILDING 1
328	SECONDARY CONTROL BUILDING 2
329	SECONDARY CONTROL BUILDING 3
330	SECONDARY CONTROL BUILDING 4
331	SECONDARY CONTROL BUILDING 5
332	SECONDARY CONTROL BUILDING 6
333	AREA CONTROL CENTER 3
334	WAS PUMP STATION 1
335	WAS PUMP STATION 2
336	HCL GAS CLEANING BUILDING
337	PICKLE LIQUOR STORAGE BUILDING
338	PICKLE LIQUOR OXIDATION BUILDING
339	PICKLE LIQUOR FACILITY
340	MIS FLOW CONTROL STRUCTURE
341	(NOT USED)
342	CHLORINE CONTACT BASIN
343	(NOT USED) (Demolished CHLORINE UNLOADING STATION)
344	FLUID STORAGE BUILDING
345	(NOT USED)
346	DISINFECTION BUILDING
347	EFFLUENT PUMP STATION
348	PLANT EFFLUENT CONDUIT
349	PLANT EFFLUENT CONDUIT & ROCK REEF
350	(NOT USED)
351	JUNCTION STRUCTURE GUARD STATION
352	ANAEROBIC DIGESTERS
353	DIESTERS GALLERY
354	DIESTER GAS STORAGE
355	COMPRESSOR BUILDING
356	INTERPLANT SOLIDS PUMP STATION
357	DISINFECTION FACILITY
358	SLUDGE THICKENER BUILDING (NEW)
359	SLUDGE DEWATERING BUILDING PHASE I
360	DEWATERING BUILDING PHASE II
361	(NOT USED) (Demolished INCINERATOR BUILDING)
362	SLUDGE LAGOONS
363	(NOT USED) (was PRIMARY SLUDGE SCREENING FACILITY)
364	UTILITY TUNNEL 14
365	UTILITY TUNNEL 13
366	UTILITY TUNNEL 1
367	UTILITY TUNNEL 2
368	UTILITY TUNNEL 3
369	UTILITY TUNNEL 4
370	UTILITY TUNNEL 5
371	UTILITY TUNNEL 6
372	UTILITY TUNNEL 7
373	UTILITY TUNNEL 8
374	UTILITY TUNNEL 9
375	UTILITY TUNNEL 10
376	UTILITY TUNNEL 11
377	UTILITY TUNNEL 12
378	ADMINISTRATION BUILDING
379	UTILITY TUNNEL 15
380	MAINTENANCE BUILDING A
381	MAINTENANCE BUILDING B
382	MAINTENANCE BUILDING C
383	AGRI-LIFE OPERATIONS BUILDING
384	TRUCK WASH FACILITY
385	SLUDGE CONTAINER BUILDING
386	MAINTENANCE BUILDING D (DAM Project 3600-2)
387	EXPERIMENTAL SLUDGE DEWATERING BUILDING
388	ELECTRICAL SUBSTATION, SWGR-25.4kV, SWGR-4.15kV, LCUS-1
389	LCUS-2
390	LCUS-3
391	RESERVOIR
392	LCUS-4
393	PRIMARY UNDERDRAIN STATION
394	SECONDARY UNDERDRAIN STATION
395	NORTH POTABLE WATER METER MANHOLE
396	NORTH BACKFLOW PREVENTER VAULT
397	SOUTH POTABLE WATER METER MANHOLE
398	SOUTH BACKFLOW PREVENTER VAULT
399	GUARDHOUSE

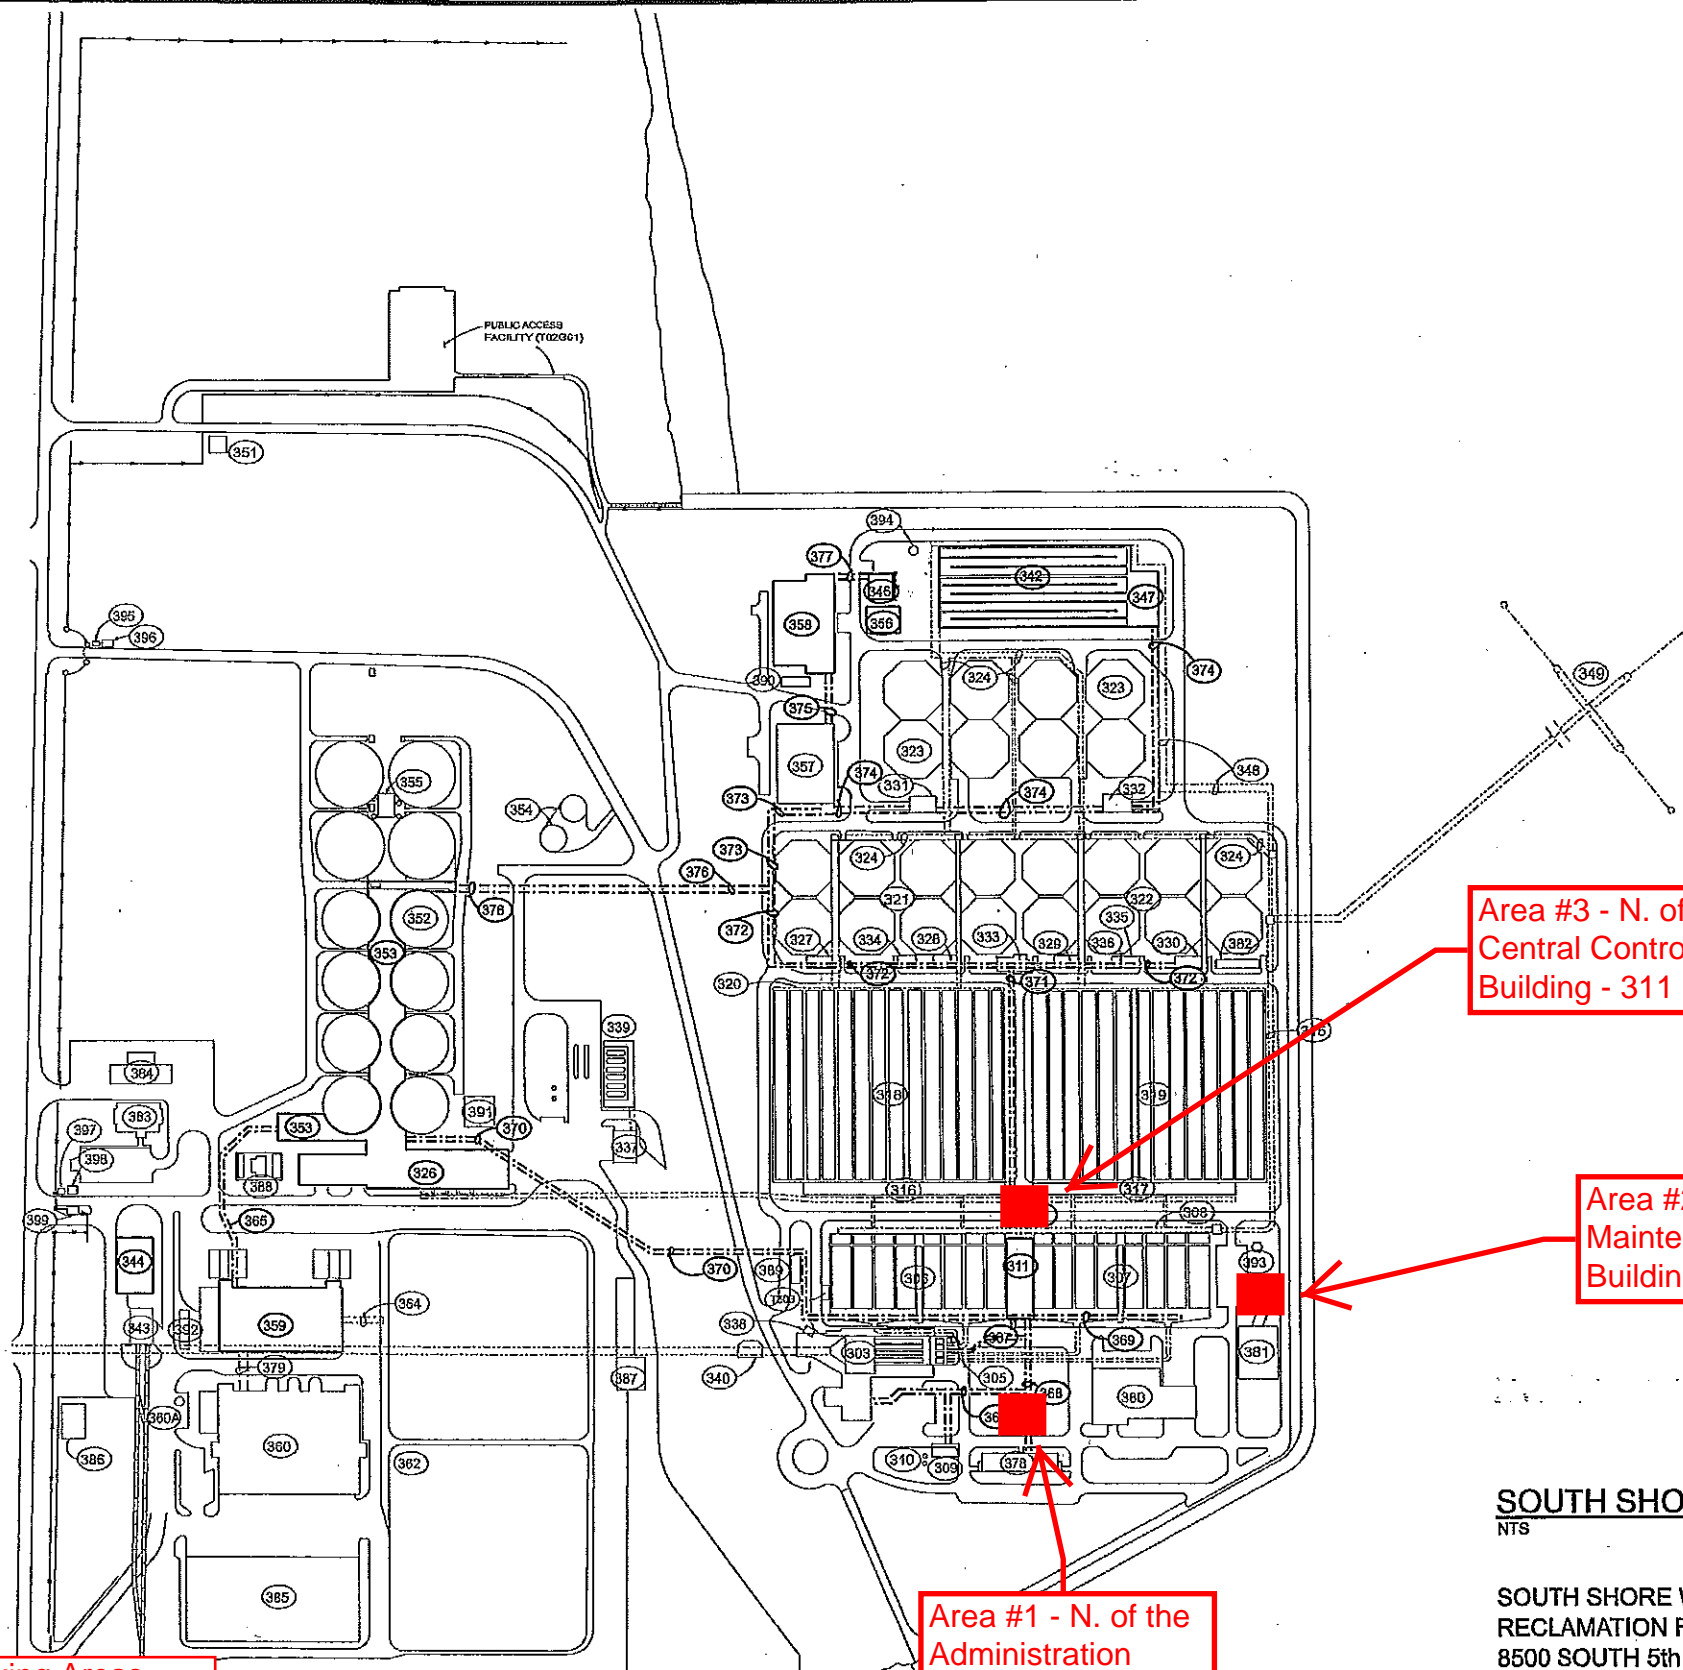

Area #3 - N. of the Central Control Building - 311

Area #2 - N. of the Maintenance Building - 381

Area #1 - N. of the Administration Building - 378

Designated Smoking Areas (#1 thru #3) - Effective 12/17/14

SOUTH SHORE SITE MAP
NTS

SOUTH SHORE WATER RECLAMATION FACILITY
8500 SOUTH 5th AVENUE
OAK CREEK, WISCONSIN

RECORD DRAWING

REUSE OF DOCUMENTS THIS DOCUMENT AND THE IDEAS AND DESIGNS INCORPORATED HEREIN IS AN INSTRUMENT OF PROFESSIONAL SERVICE AND IS NOT TO BE USED, IN WHOLE OR IN PART, FOR ANY OTHER PROJECT WITHOUT THE WRITTEN AUTHORIZATION OF THE MILWAUKEE METROPOLITAN SEWERAGE DISTRICT.	VERIFY SCALES BAR IS ONE INCH ON ORIGINAL DRAWING IF NOT ONE INCH ON THIS SHEET, ADJUST SCALES ACCORDINGLY.	DSGN P. FLEWA	This Design Prepared For MMSD By: SYMBIONT		REV. 1 6-17-11 REV. NO. DATE	RECORD DRAWING - NO REDLINE CHANGES REVISION DESCRIPTION	MSK PWC BY APVD		MILWAUKEE METROPOLITAN SEWERAGE DISTRICT SOUTH SHORE WATER RECLAMATION FACILITY EFFLUENT PUMPING, FACILITY BUILDING HVAC AND SLUICE GATE IMPROVEMENTS GENERAL SOUTH SHORE SITE MAP	DRAWING NO.: S060-G-4
		CHK P. CARNAHAN APVD P. CARNAHAN	SHEET: 4							
									DATE: JUNE 2009	
									CONTRACT: S06013C01	
									MMSD FILE: S098G004r01.dgn	